



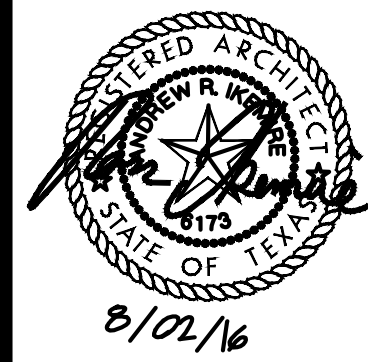


ELECTRICAL SYMBOLS	
	TELEVISION OUTLET
	NATURAL GAS SERVICE
	WALL BRACKET
	EXHAUST FAN

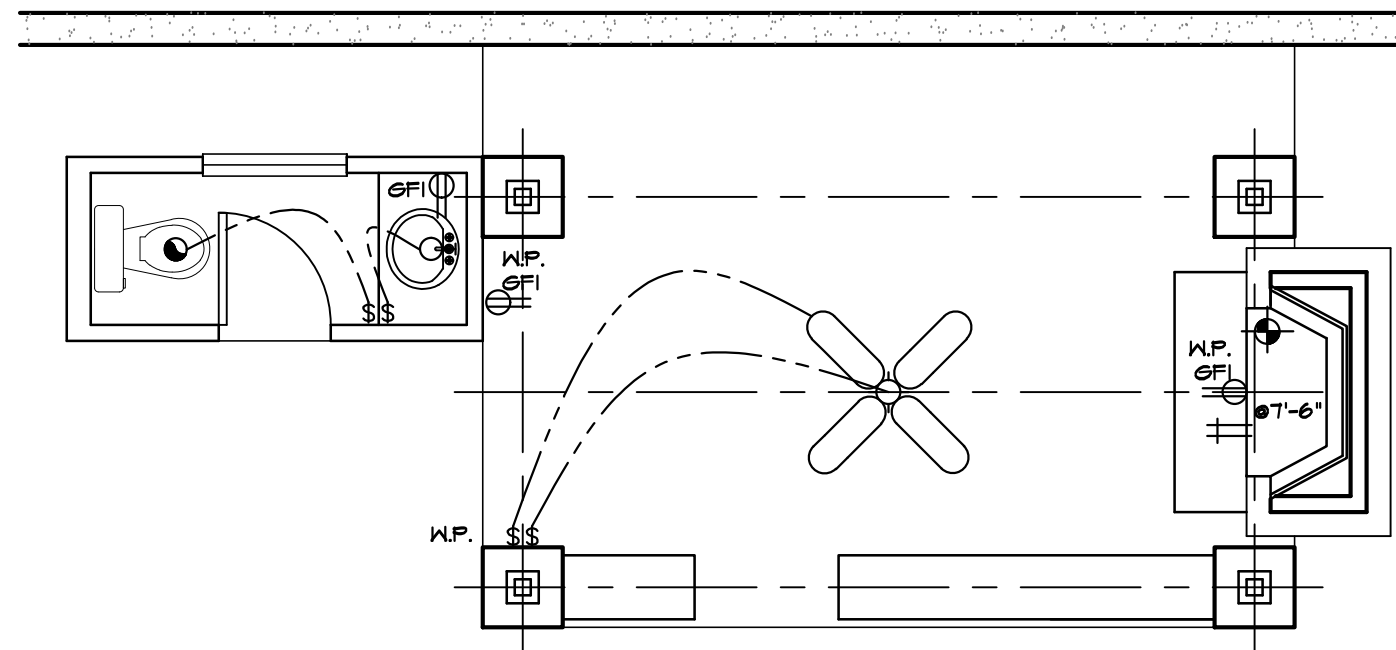


ELECTRICAL PLAN

SCALE: 1/4"=1'-0"

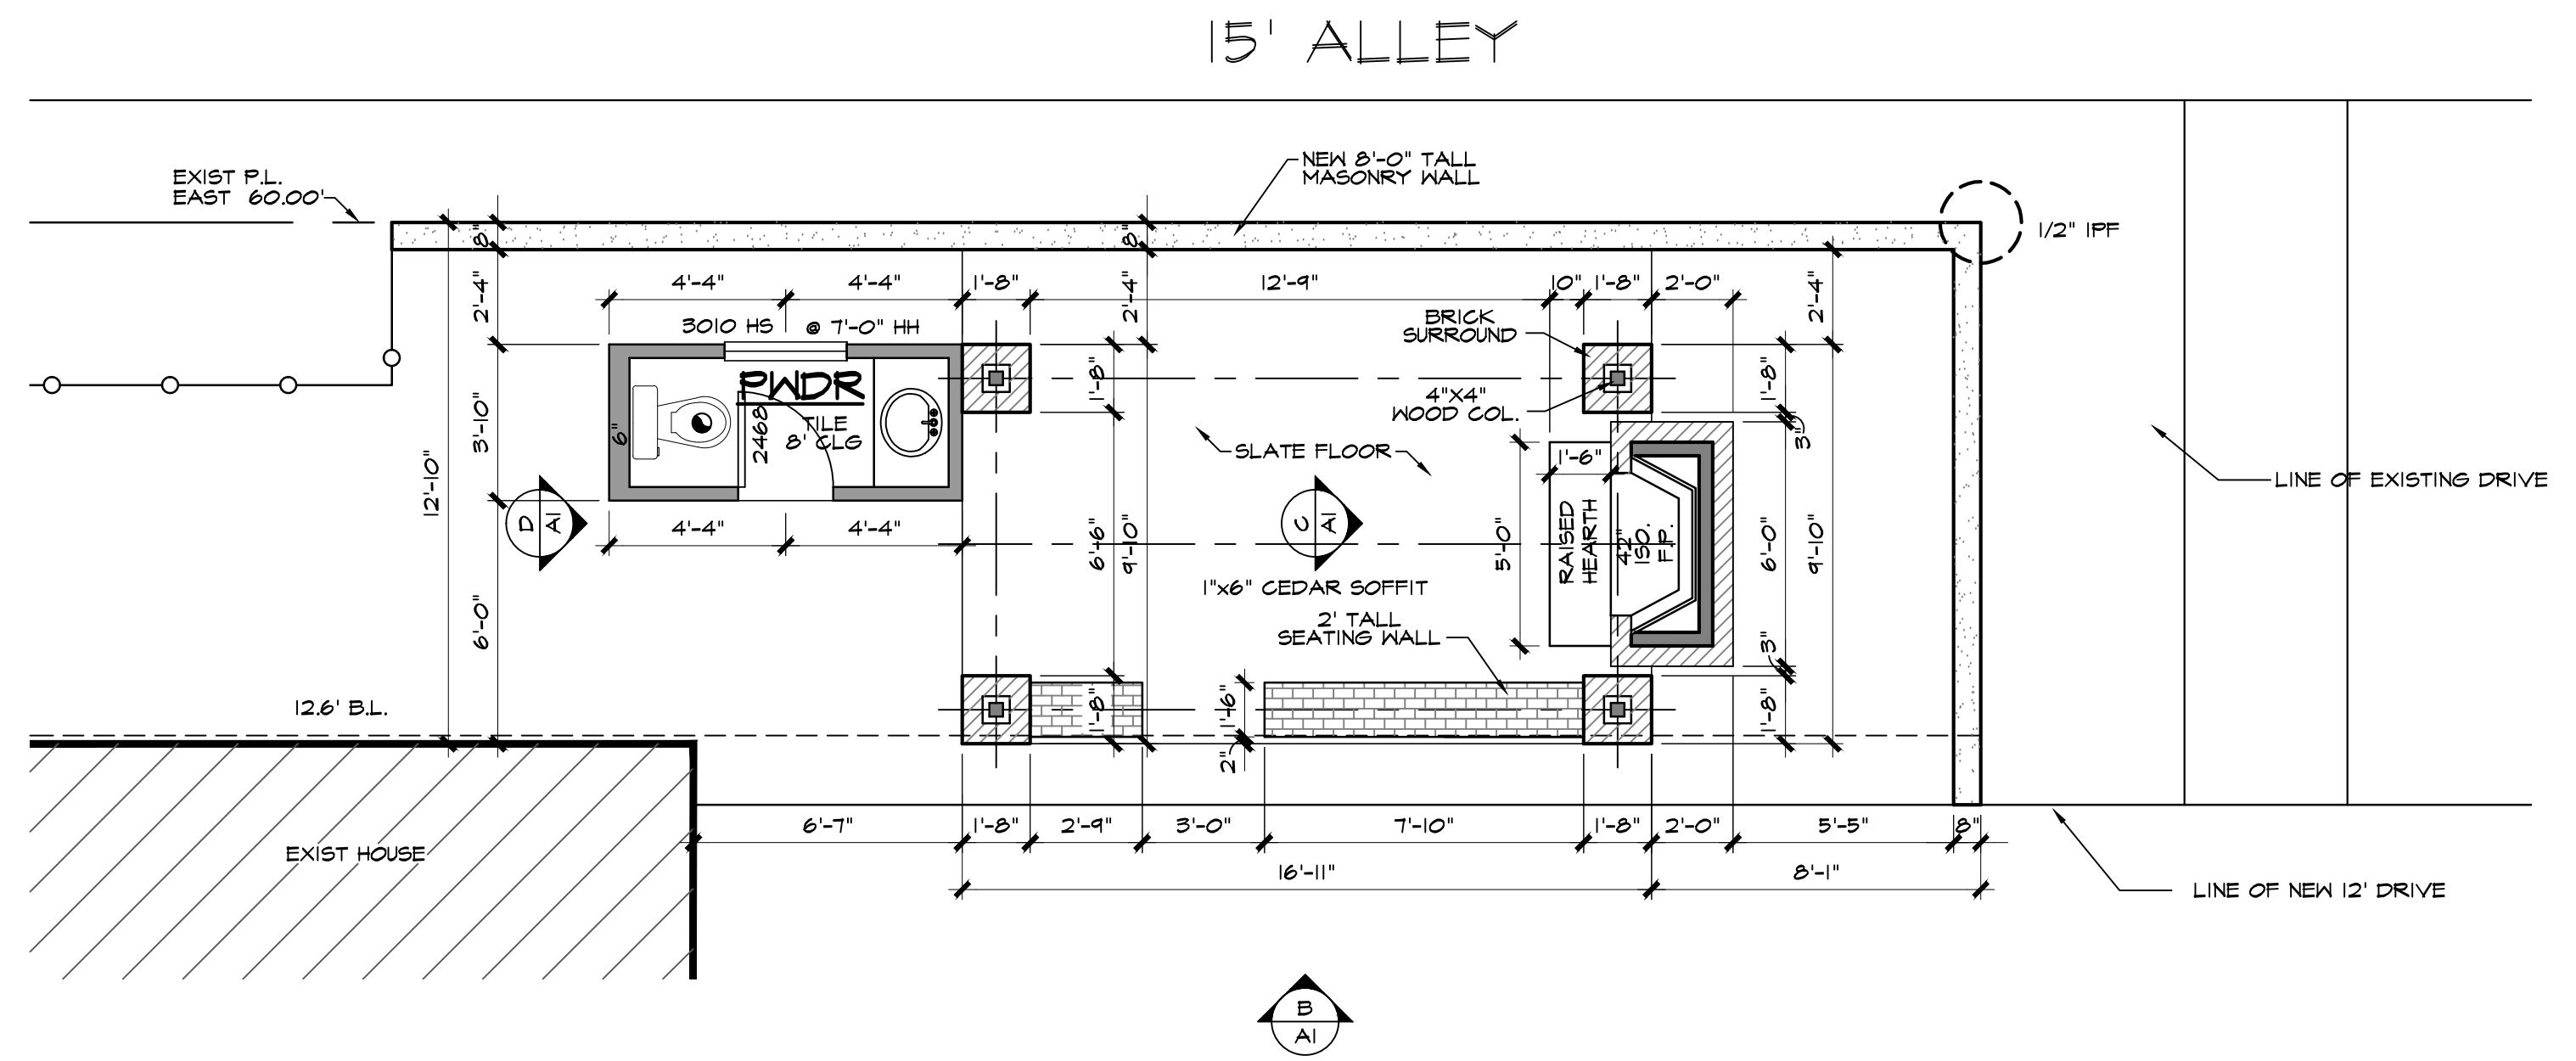


PLAN - A

SCALE: 1/4"=1'-0"

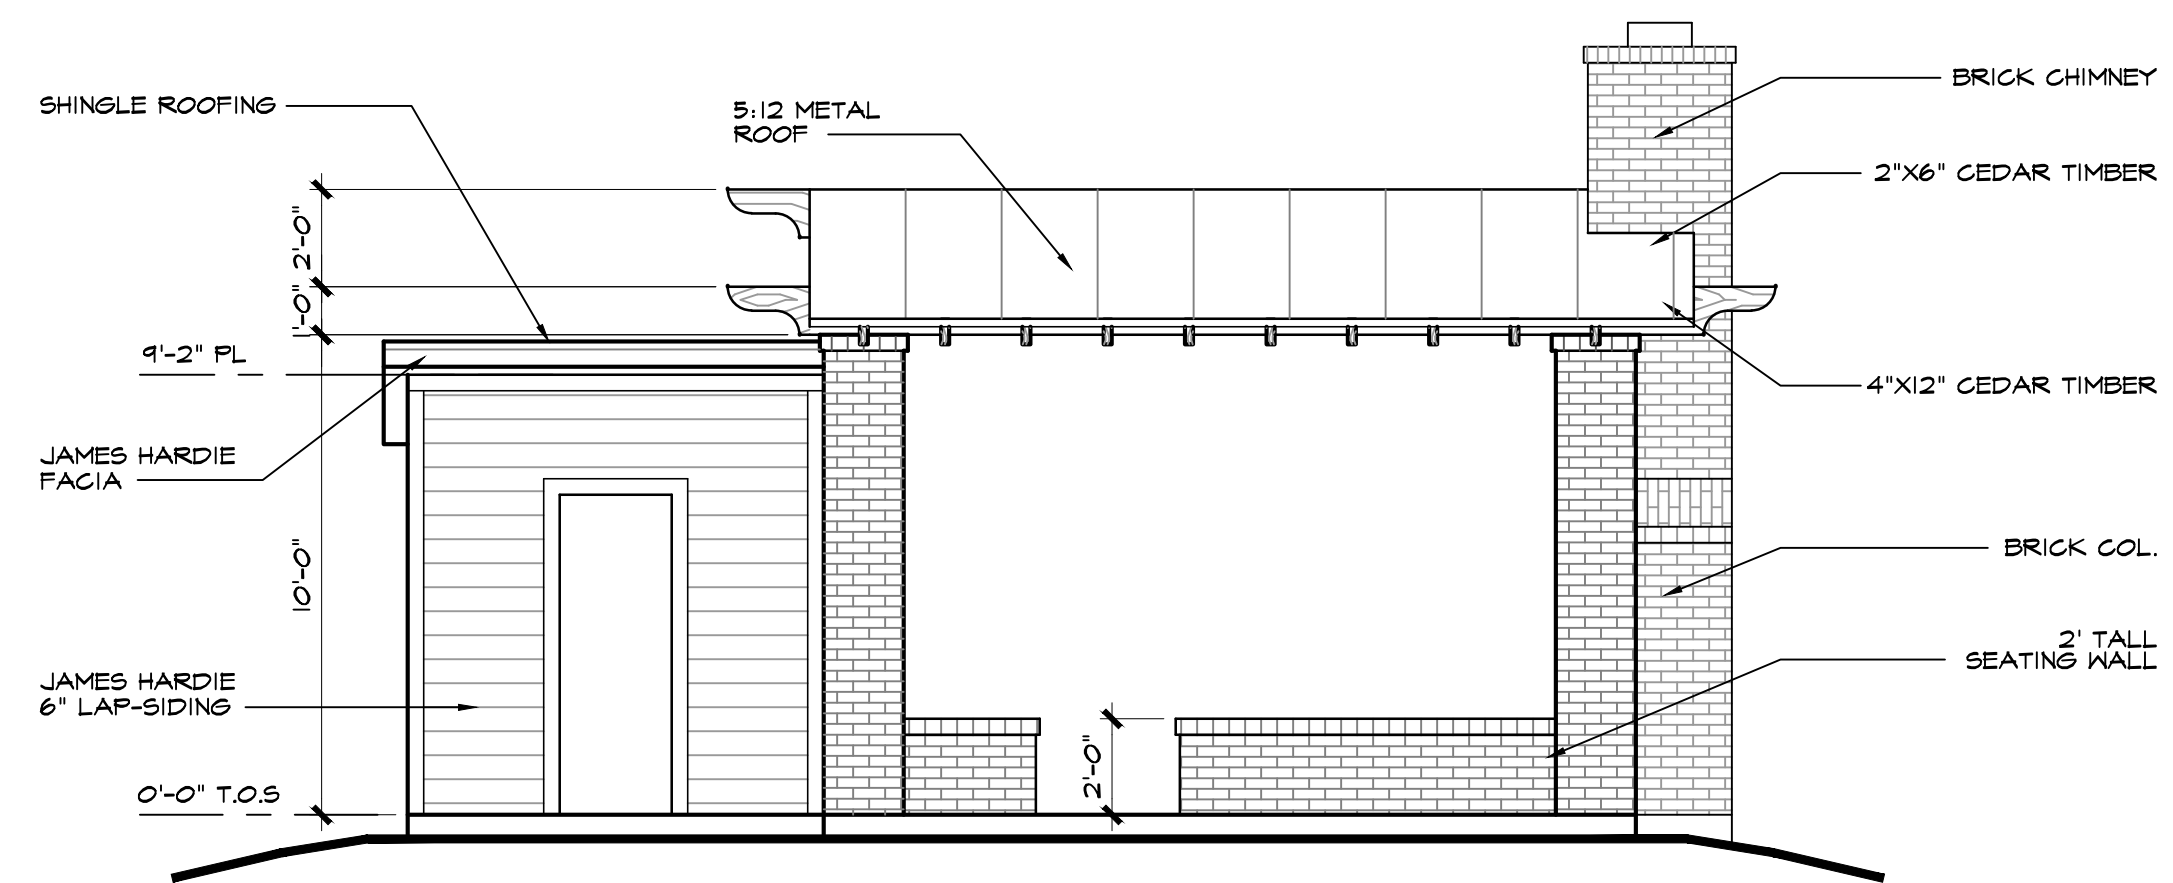


ELEVATION - B

SCALE: 1/4"=1'-0"

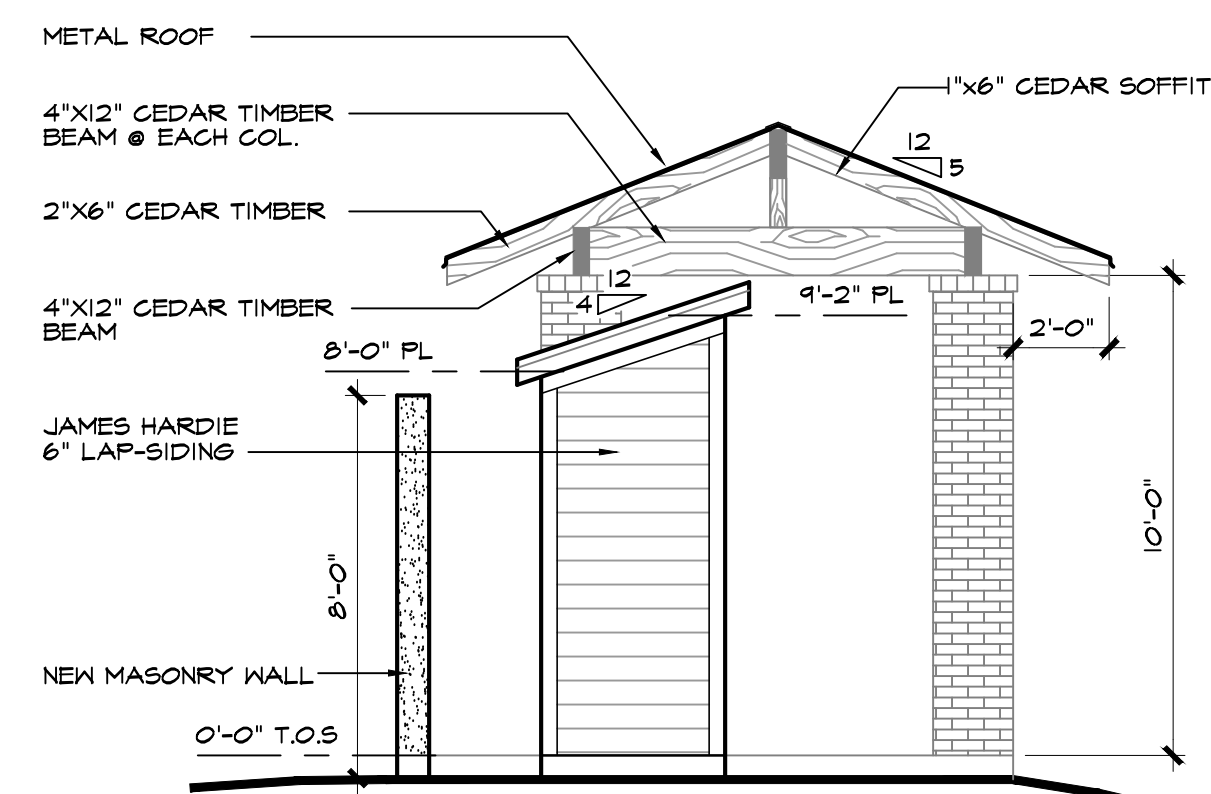

ELEVATION - D

SCALE: 1/4"=1'-0"

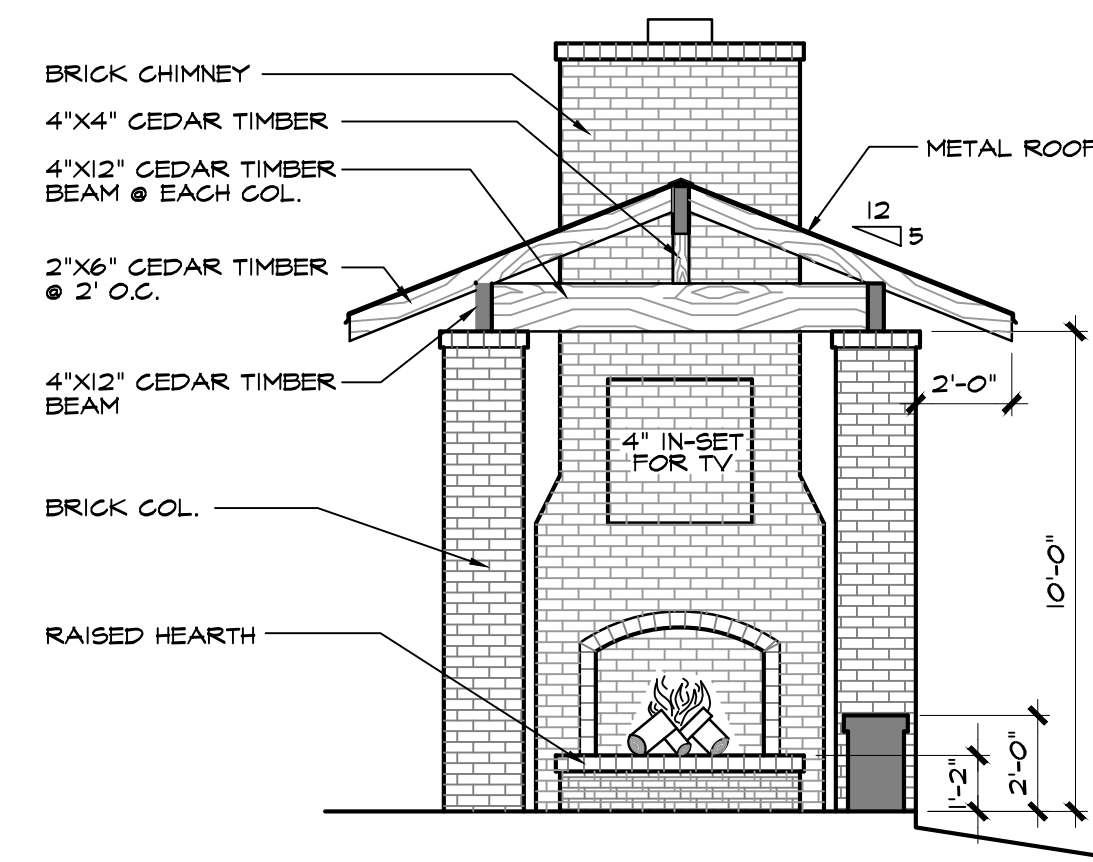

ELEVATION - C

SCALE: 1/4"=1'-0"